


RCP LEGEND

| | |
|---|--|
| CEILING TYPE HATCHES | CEILING TAG DIAGRAM |
| 2x4 LAY-IN CEILING PANEL | CEILING TYPE: SEE ASSEMBLY SHEET |
| 2X2 LAY-IN CEILING PANEL | HEIGHT (FEET, INCHES) ABOVE FINISHED FLOOR |
| GYPSUM BOARD | LIGHT FIXTURE DIAGRAMS |
| EXPOSED STRUCTURE | 2x4 FIXTURE |
| WOOD CEILING | X 2 FIXTURE |
| INSULATED CEILING | POINT FIXTURE |
| MECHANICAL TAGS | LINEAR FIXTURE |
| SUPPLY AIR DIFFUSER | DOWNLIGHT |
| RETURN AIR DIFFUSER | DIRECTIONAL DOWNLIGHT |
| LINEAR SUPPLY DIFFUSER | WALL SCONCE |
| CEILING ACCESS PANEL (PTD), COORDINATE FINAL LOCATION WITH MECH DWGS. | CEILING FAN |

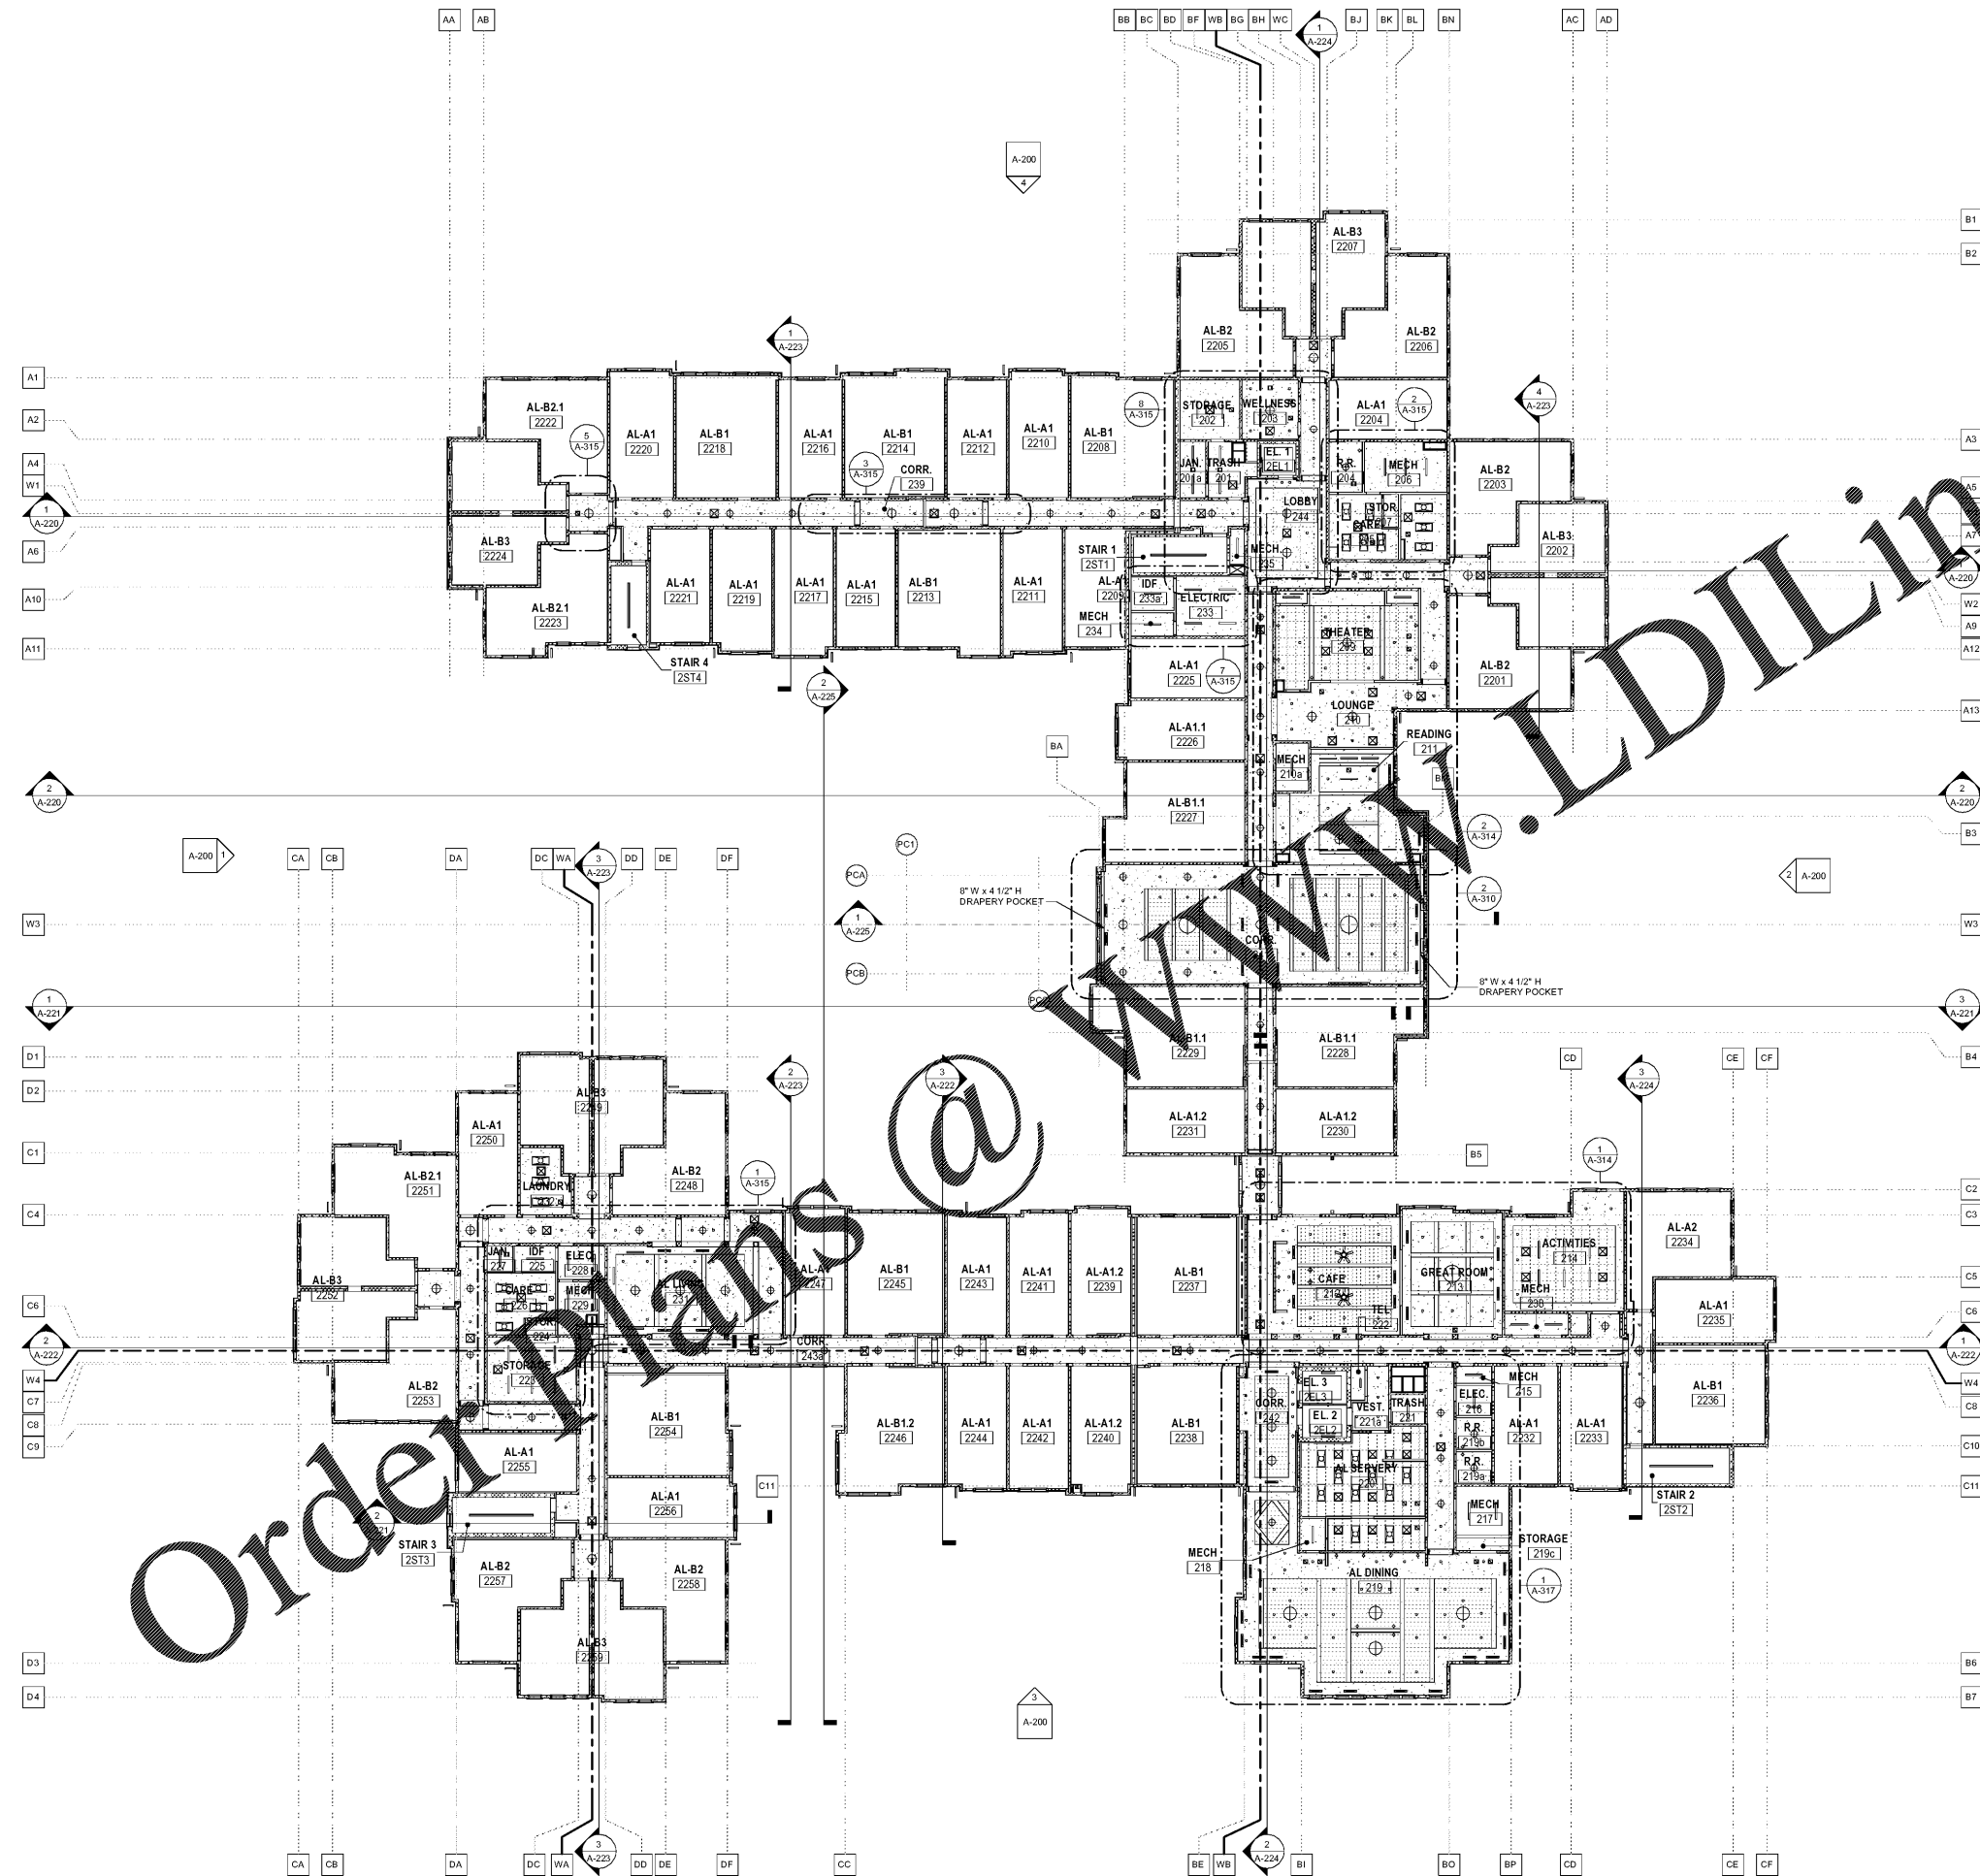

1 OVERALL REFLECTED CEILING PLAN - SECOND FLOOR
A-172 1/16" = 1'-0"