

architect | designer
BCT ARCHITECTS
 100 North Charles Street, 18th floor
 Baltimore, MD 21201
 410.837.2727
 www.bctarchitects.com

structural engineer
CARROLL ENGINEERING, INC.
 215 Shilling Circle, Suite 102
 Hunt Valley, MD 21031
 410.785.7423
 www.carrolleengineering.com

mep engineer
KIBART, INC.
 901 Dulaney Valley Road, Suite 301
 Towson, MD 21284
 410.454.1111
 www.kibart.com

civil engineer
H.A. Inc.
 29A Leinback Drive
 Charleston, SC 29407
 1.843.752.1166
 www.hainc.com

landscape architect
LAND DESIGN, LLC
 200 South Peyton Street
 Alexandria, VA 22314
 1.703.542.7754
 www.LandDesign.com

interior designer
AJMEEN ASNER
 100 North Charles Street, Suite 910
 Baltimore, MD 21201
 410.837.2767
 www.ajmeenasner.com

code & life safety consultant
KOFFEL ASSOCIATES, INC.
 8815 Centre Park Dr., Suite 200
 Columbia, MD 21045
 410.794.1610
 www.koffel.com

project
 DHEC Project Number #: 637063
BEES FERRY SENIOR LIVING
 3097 Bees Ferry Road
 Charleston, South Carolina 29414

client | owner
3097 BEES FERRY ROAD, LLC
 3535 Colonel Vandewater Circle
 Mount Pleasant, SC 29466
 1.843.296.3985

seal | signature

10/18/2019

revisions

No.	Date	Title


sheet title

PARTIAL POWER PLAN - LEVEL 3 - PART A

issue date 10/18/2019

sheet number


E-230

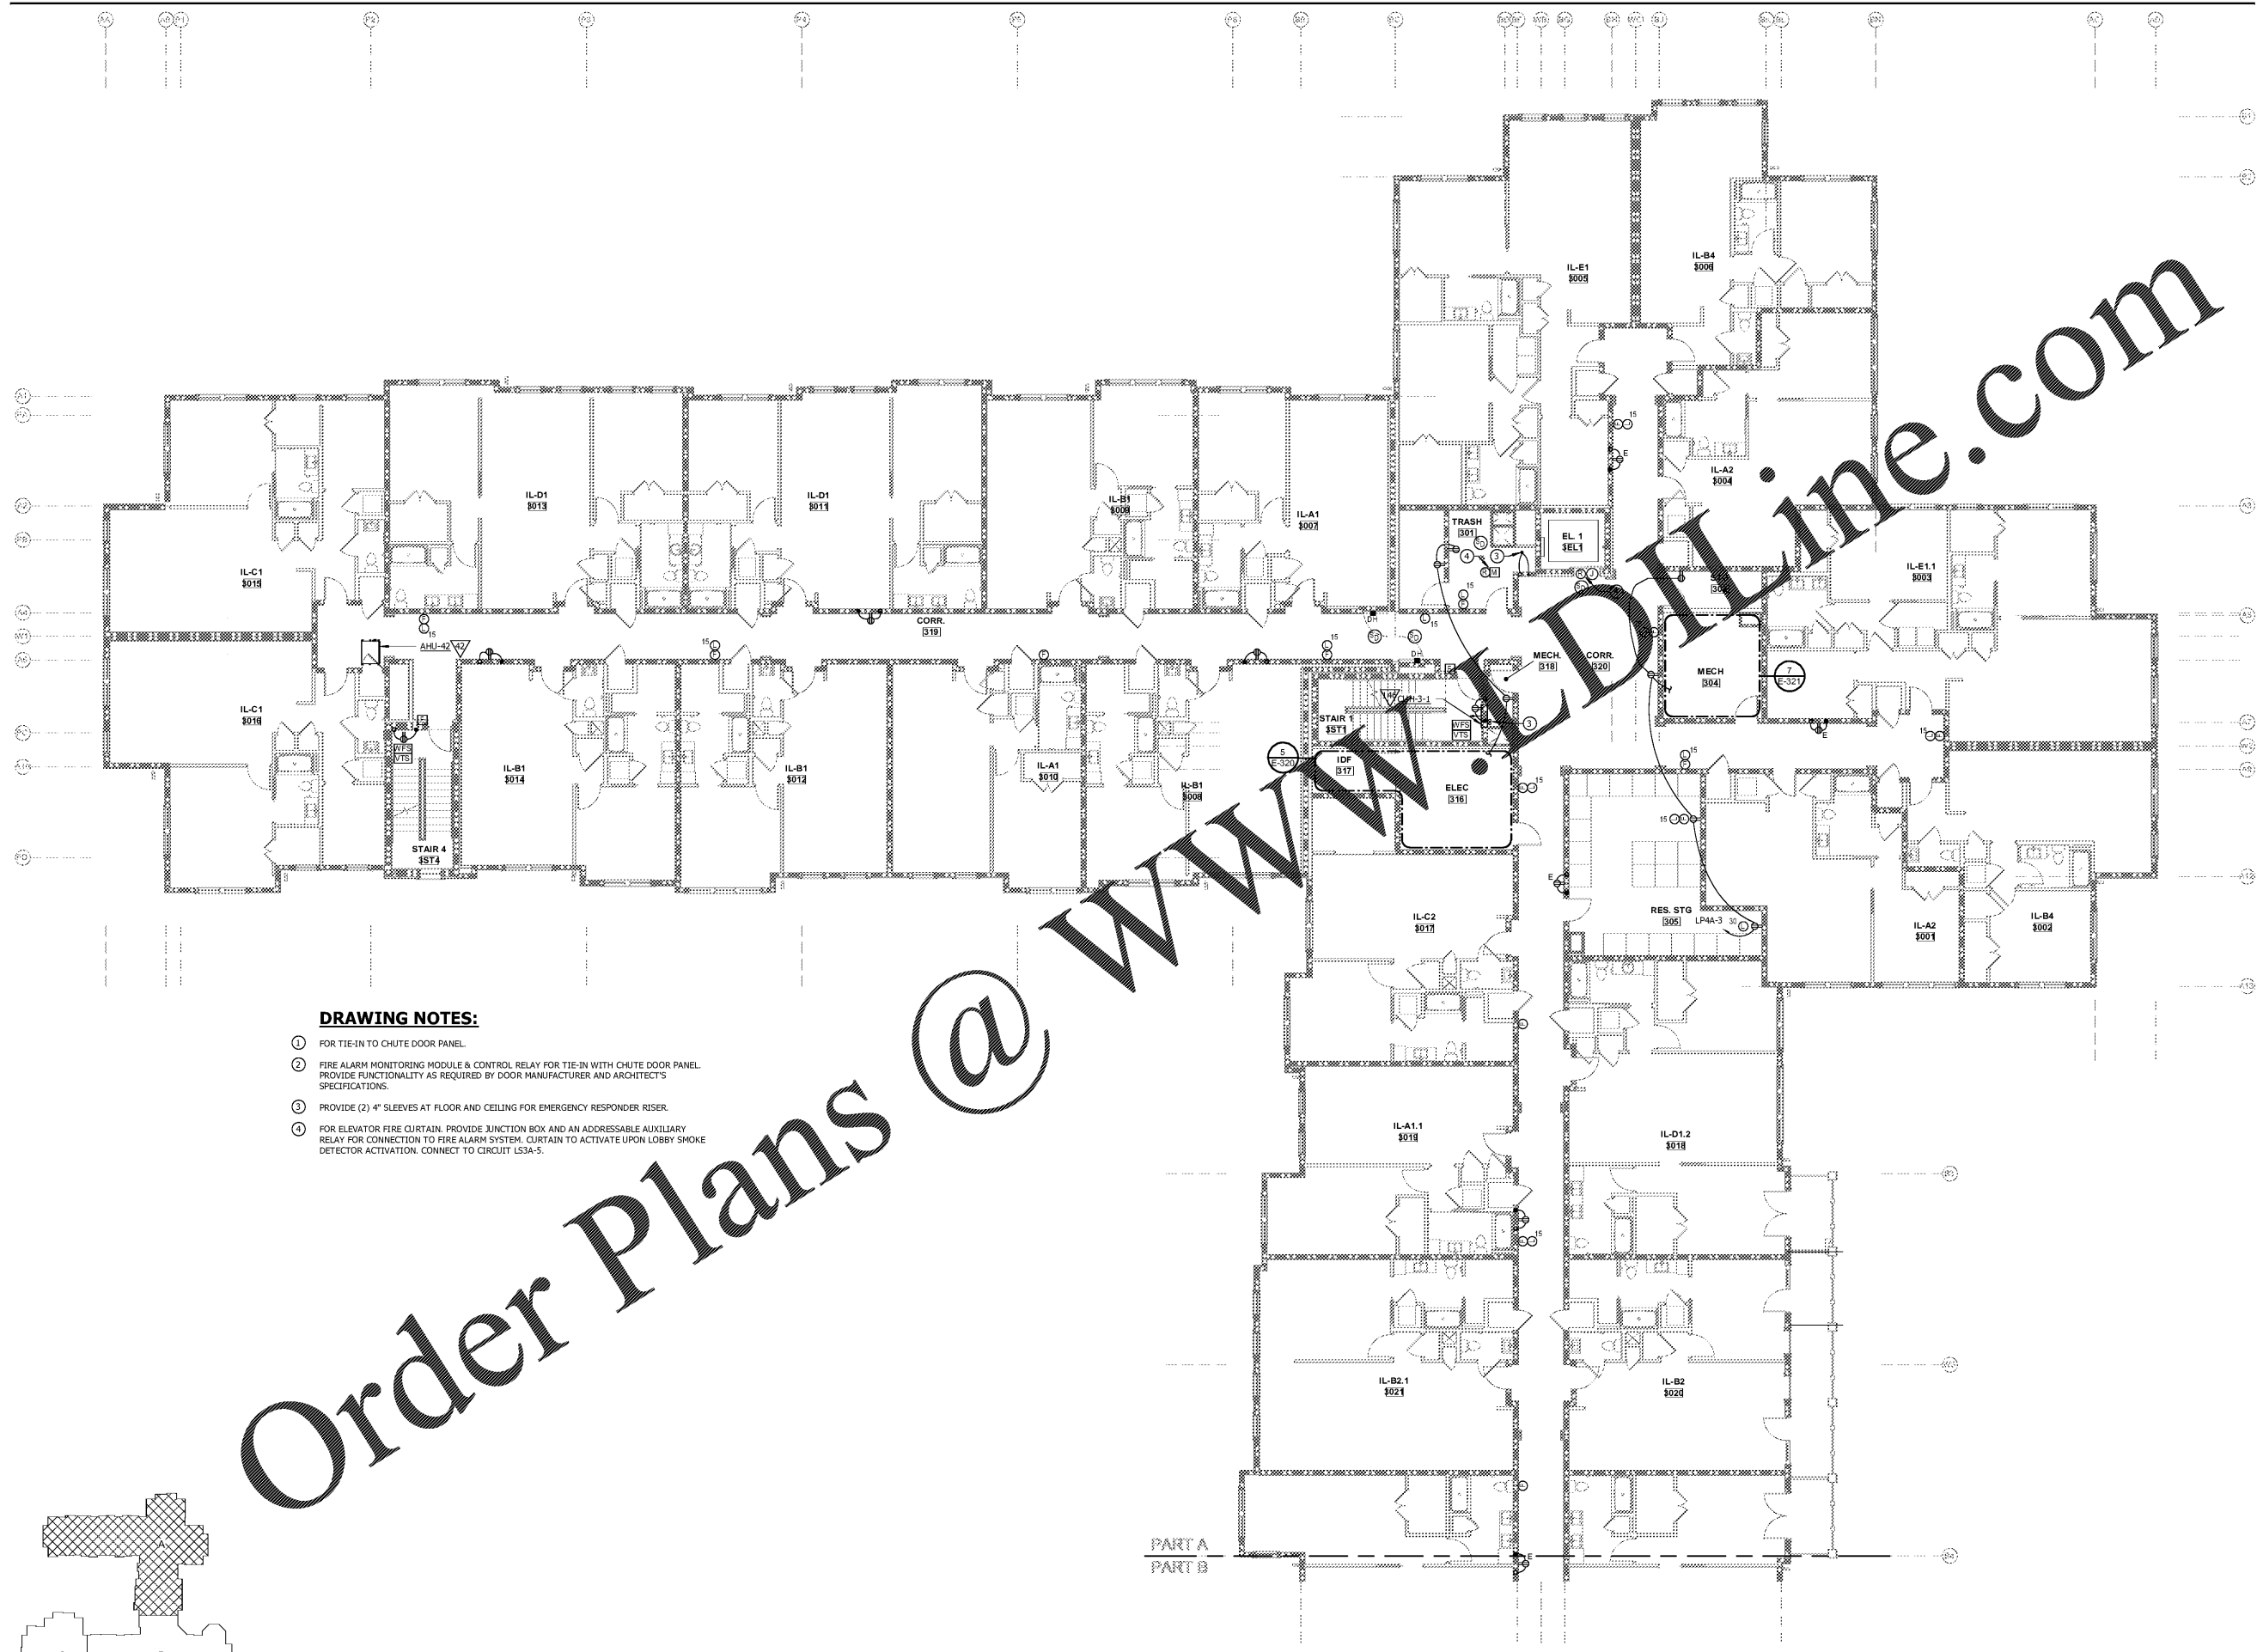

DRAWING NOTES:

- ① FOR TIE-IN TO CHUTE DOOR PANEL.
- ② FIRE ALARM MONITORING MODULE & CONTROL RELAY FOR TIE-IN WITH CHUTE DOOR PANEL. PROVIDE FUNCTIONALITY AS REQUIRED BY DOOR MANUFACTURER AND ARCHITECT'S SPECIFICATIONS.
- ③ PROVIDE (2) 4" SLEEVES AT FLOOR AND CEILING FOR EMERGENCY RESPONDER RISER.
- ④ FOR ELEVATOR FIRE CURTAIN. PROVIDE JUNCTION BOX AND AN ADDRESSABLE AUXILIARY RELAY FOR CONNECTION TO FIRE ALARM SYSTEM. CURTAIN TO ACTIVATE UPON LOBBY SMOKE DETECTOR ACTIVATION. CONNECT TO CIRCUIT L53A-5.

Order Plans @ WWW.DIline.com

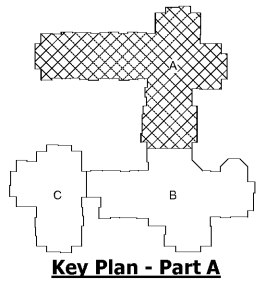

THIRD FLOOR POWER - A
 SCALE: 1/8" = 1'-0"

