


revisions


No.	Date	Title

sheet title

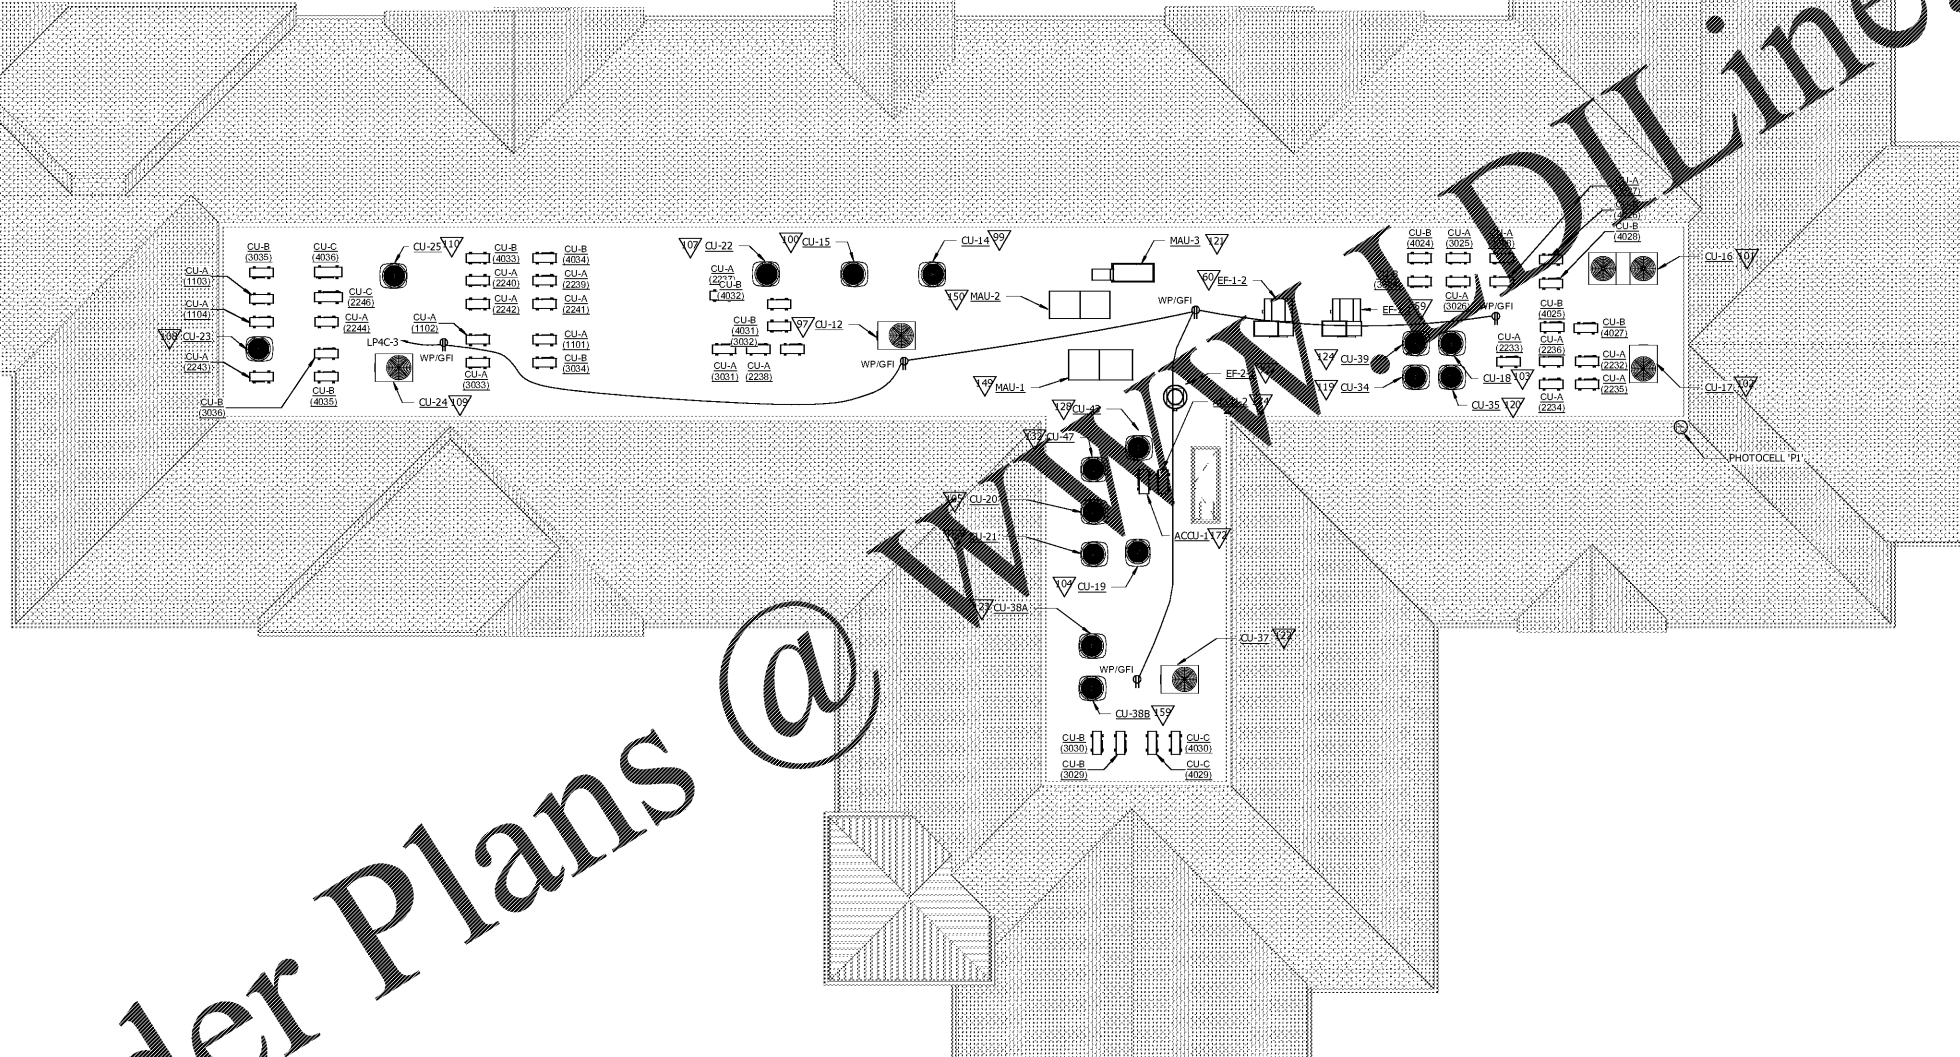

Order Plans @ [www.DIline.com](http://www.DIline.com)

**ROOF PART PLAN - ELECTRICAL - B**  
 SCALE: 1/8" = 1'-0"

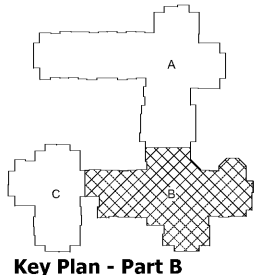

SCALE: 1/8" = 1'-0"

- GENERAL NOTES:**
- ALL ROOF MOUNTED RECEPTACLES SHALL BE STUB-UP TYPE.
  - CONDUCTORS ROUTED ON ROOF SHALL BE UPSIZED FOR AMBIENT TEMPERATURE PER NEC 310.15(B)(3).
  - COORDINATE CU'S WITH MECHANICAL PLANS FOR ACTUAL ASSOCIATED APARTMENT NUMBER TO KNOW WHICH CU UNIT IS CONNECTED TO WHICH APARTMENT.
- HVAC CONNECTION NOTES:**
- REFER TO SHEET E-612 FOR CONNECTION OF CU-X. CU-X SHALL BE CONNECTED AS FOLLOWS:
- ▽ CU-A
  - ▽ CU-B
  - ▽ CU-C