


Order Plans @

NOTE 1. THE ELECTRICIAN SHALL INSTALL ADDITIONAL #12 WIRE TIE SUPPORTS FROM THE CEILING GRID TO THE STRUCTURE ABOVE FOR SUPPORT OF THE LIGHT FIXTURES CLIPPED ON THE GRID.
 NOTE 2. LIGHT FIXTURES TENANT SUPPLIED / CONTRACTOR INSTALLED.
 NOTE 3. MOUNT LIGHTS 10'-0" AFF IN STOCKROOM.

REFLECTED CEILING LEGEND	
	2'-0" x 4'-0" ACOUSTICAL CEILING TILE AND TEE GRID SYSTEM - REFER TO FINISH SCHEDULE.
	GWB - 1/2" GWB ON 3 5/8" METAL STUDS 16 OC. REFER TO FINISH SCHEDULE.
	8'-0" STRIP LED LIGHT FIXTURE WITH LAMPS ON NIGHT LIGHT CIRCUIT. SURFACE MOUNT TO GWB AND ACT CEILING. HANG AT 11'-6" AFF SALES AREA / 10'-0" AFF STOCKROOM IF NO CEILING.
	8'-0" STRIP LED LIGHT FIXTURE. SURFACE MOUNT TO GWB AND ACT CEILING. HANG AT 11'-6" AFF SALES AREA / 10'-0" AFF STOCKROOM IF NO CEILING.
	8'-0" STRIP LED LIGHT FIXTURE WITH LAMPS ON EMERGENCY LIGHT CIRCUIT WITH BATTERY PACK. SURFACE MOUNT TO GWB AND ACT CEILING. FOR FIXTURES WITH 4 LAMPS, THE EMERGENCY BATTERY PACK WILL ONLY OPERATE 2 OF THE LAMPS. HANG AT 11'-6" AFF SALES AREA / 10'-0" AFF STOCKROOM IF NO CEILING.
	4'-0" STRIP LED LIGHT FIXTURE WITH LAMPS ON NIGHT LIGHT CIRCUIT. SURFACE MOUNT TO TO GWB AND ACT CEILING.
	4'-0" STRIP LED LIGHT FIXTURE. SURFACE MOUNT TO ACT AND GWB CEILING.
	4'-0" STRIP LED LIGHT FIXTURE WITH LAMPS ON EMERGENCY LIGHT CIRCUIT WITH BATTERY PACK. SURFACE MOUNT TO TO GWB AND ACT CEILING.
	EXIT LIGHT
	WALL MOUNTED LIGHT FIXTURE
	CEILING HEIGHT ABOVE FINISH FLOOR
	VENTILATION FAN
	DIFFUSER
	RETURN AIR GRILLE
	POWER POLE
	SECURITY MONITOR
	SPRINKLER HEAD (SHOWN FOR INFORMATIONAL PURPOSES ONLY. SPRINKLER CONTRACTOR SHALL PREPARE DRAWINGS AS REQUIRED BY CODE FOR RELOCATION OR ADDITION OF HEADS.)

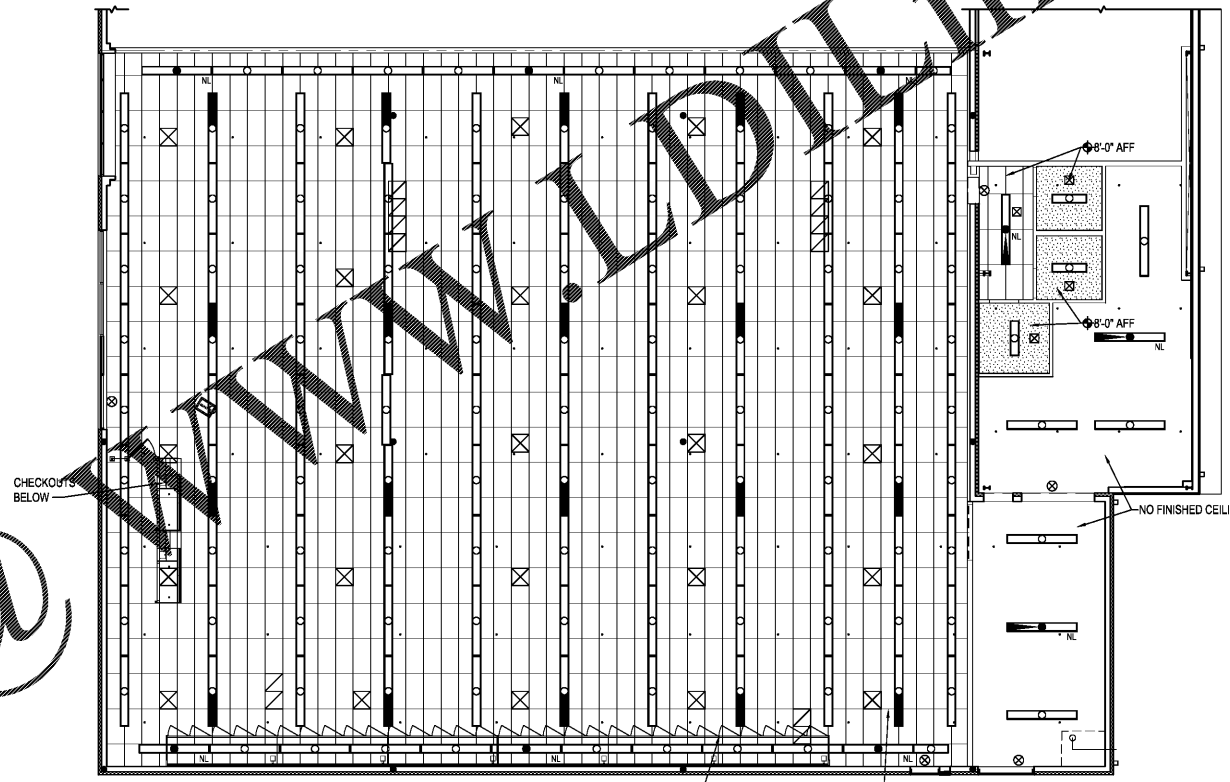

REFLECTED CEILING PLAN
 SCALE: 1/8" = 1'-0"



--	--

2-6-2020	2018-03	CSY	CSY	DAE
date	project	designed	drawn	checked

RRMM ARCHITECTS, P.C.
 1317 Executive Blvd, Suite 200
 Chesapeake, VA 23320
 (757) 622-2828 / fax (757) 622-6883



FAMILY DOLLAR
 FAMILY DOLLAR STORE FDS #791567
 501 TENNESSEE AVE NORTH - FARMINGTON, TN 38283
 REFLECTED CEILING PLAN AND LEGEND