

REFLECTED CEILING PLAN SHEET NOTES


- SEE SHEET A-003 FOR PARTITION TYPES AND HEIGHT OF WALLS ABOVE CEILING.
- SEE FINISH SCHEDULE ON SHEET A-720 FOR CEILING TYPES & MATERIALS IN EACH ROOM / AREA.
- PERIMETER TRACK FOR ALL ACOUSTICAL CEILING GRIDS TO BE 2" WIDE INSTALLED IN ACCORDANCE WITH IBC AND CBSA GUIDELINES.
- DIMENSIONS ARE TO FACE OF WALL OR MASONRY.
- CEILING GRIDS/TILES TO BE CENTERED IN ALL ROOMS UNLESS NOTED OTHERWISE. PARTIAL TILES AT ROOM PERIMETERS SHALL NOT BE LESS THAN 6" IN EITHER DIMENSION.
- ALL CEILINGS TO BE 9'-0" AFF. UNO. CEILING HEIGHTS SHOWN ON THE REFLECTED CEILING PLANS ARE NON-TYPICAL AND SPECIFIC TO THE AREA INDICATED. REFER TO INTERIOR ELEVATIONS FOR THE HEIGHTS OF SPACES ABOVE CASEWORK.
- SEE ELECTRICAL, FIRE ALARM AND FIRE PROTECTION DRAWINGS FOR SPECIAL SYSTEMS, SMOKE DETECTORS, LIGHTING AND WALL MOUNTED FIXTURES NOT SHOWN ON THIS SHEET. COORDINATE LOCATIONS OF ALL FIXTURES NOT INDICATED WITH LAYOUT INDICATED ON THIS SHEET.
- LIGHT FIXTURES AND MECHANICAL DIFFUSERS ARE SHOWN FOR POSITIONING IN FINISH CEILING SYSTEM. COORDINATE WITH MECHANICAL AND ELECTRICAL DRAWINGS FOR FIXTURE TYPES, MECHANICAL DIFFUSERS, WALL MOUNTED FIXTURES AND INSTALLATION OF FIXTURES IN SPACES WITHOUT CEILINGS. (LIGHTING AND HVAC DIFFUSERS ARE SHOWN FOR COORDINATION ONLY - SEE MECHANICAL AND ELECTRICAL DRAWINGS FOR SPECIFIC INFORMATION).
- SEE MECHANICAL FLOOR PLANS FOR EXTENT OF EXPOSED DUCTWORK IN EXPOSED STRUCTURE AREAS WITHOUT CEILINGS.
- EXTEND PERIMETER WALLS AND FINISH TO STRUCTURE AREAS AT EXPOSED STRUCTURE AREAS. PART ALL EXPOSED DUCTWORK, PIPING, DUCTS, ETC.
- SEE MECHANICAL AND ELECTRICAL DRAWINGS FOR CONTINUOUS LOCATIONS OF ITEMS WHERE NO CEILING IS INDICATED.
- CENTER LIGHTS, DIFFUSERS, EXIT SIGNS, SMOKE DETECTORS, SPEAKERS, GENERAL ALARM SPEAKERS, STROBES AND DEVICES ON CEILING AREAS WHERE THEY ARE LOCATED. ALIGN WITH TILE CENTER LINES.
- LOCATE MECHANICAL GRILLES, DIFFUSERS, EXHAUST FANS OR NEAR WALL TO 12" OFF WALL. USE GYPSUM BOARD CEILING AT DUCT DAMPER CONTROLS, DUCT MOUNTED SMOKE DETECTORS, MANUAL DUCT CONTROLS, ETC.
- ALL SINGLE LIGHT FIXTURES SHALL BE CENTERED IN THE CEILING WITHIN THEY OCCUPY.



MAINTENANCE BUILDINGS



227 WEST TRADE STREET SUITE 700  
CHARLOTTE, NORTH CAROLINA 28202  
TEL. 704.333.8888 FAX 704.333.2926  
WWW.LS3P.COM

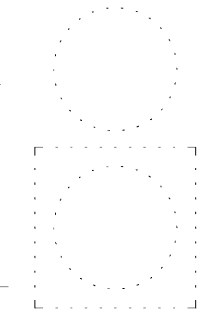


MEMBERS OF THE AMERICAN INSTITUTE OF ARCHITECTS  
COPYRIGHT 2020 ALL RIGHTS RESERVED  
PRINTED OR ELECTRONIC DRAWINGS AND DOCUMENTATION MAY NOT BE REPRODUCED IN ANY FORM WITHOUT WRITTEN PERMISSION FROM LS3P ASSOCIATES LTD.

REVISIONS:

No.	Description	Date


KEY PLAN

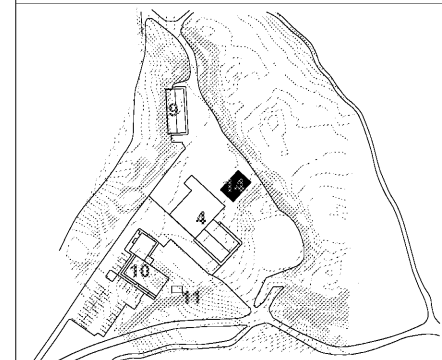


PROJECT: 9606-197950  
DATE: 19 JUNE 2020  
DRAWN BY: Author  
CHECKED BY: Checker

PHASE 1 - REFLECTED CEILING PLAN

A-121

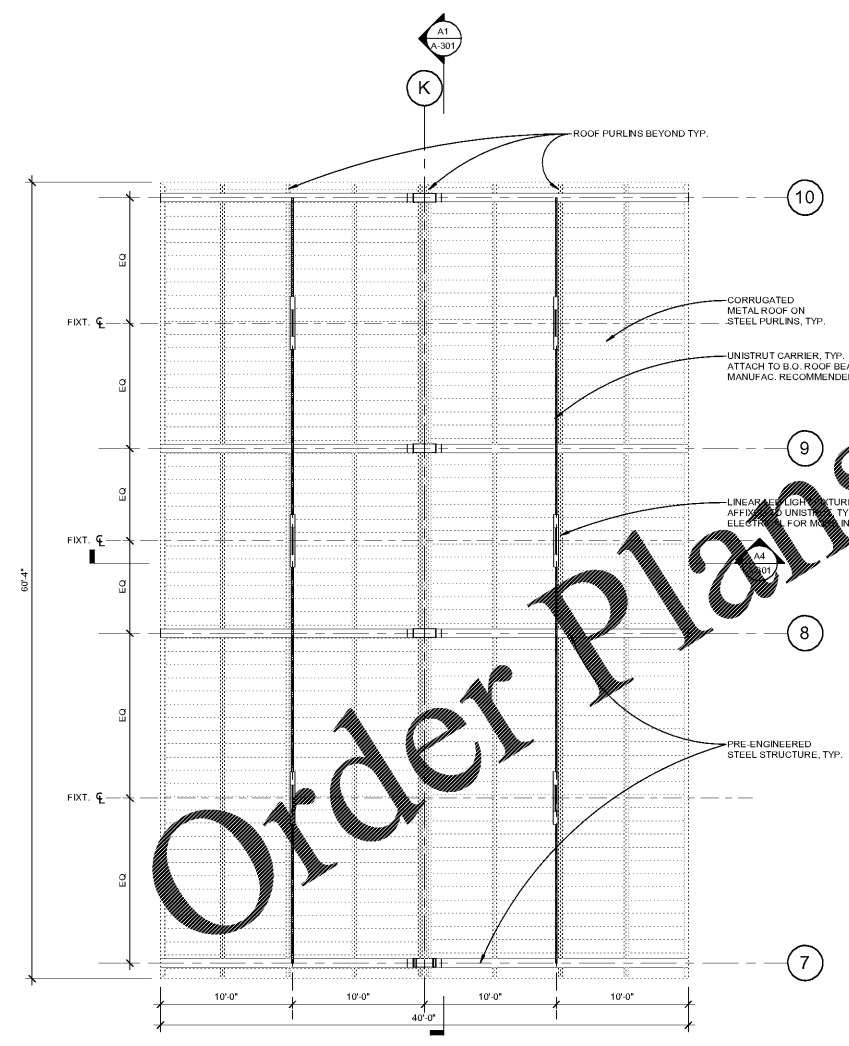

 A1 PHASE 1 REFLECTED CEILING PLAN  
3/16" = 1'-0"



BIM 360/Quail Hollow Maintenance Facilities/Arch\_OHC Maintenance Buildings\_2018.rvt  
 6/29/2020 9:35:05 PM

www.LDILine.com @ Order Plans