



**MAINTENANCE BUILDINGS**

3700 GLENEAGLES RD.  
CHARLOTTE, NC 28210

**BW**  
&A Barrett, Woodyard and Associates, Inc.  
License # C-2226

420 Market LN  
Charlotte, North Carolina 28217  
(p) 704-357-8333 (f) 704-357-8385  
This drawing is copyrighted, it may not be reproduced or used in any other form or on any other project.  
3WA J03 # 2020-0497



227 WEST TRADE STREET SUITE 700  
CHARLOTTE, NORTH CAROLINA 28202  
TEL. 704.333.8686 FAX 704.333.2926  
WWW.LS3P.COM



MEMBERS OF THE AMERICAN INSTITUTE OF ARCHITECTS

COPYRIGHT 2020 ALL RIGHTS RESERVED  
PRINTED OR ELECTRONIC DRAWINGS AND DOCUMENTATION MAY NOT BE REPRODUCED IN ANY FORM WITHOUT WRITTEN PERMISSION FROM LS3P ASSOCIATES LTD.

**REVISIONS:**


No.	Description	Date

PROJECT: 9600-197950  
DATE: 19 JUNE 2020  
DRAWN BY: NPD  
CHECKED BY: BJR

**PHASE 3 FLOOR PLAN - PLUMBING**

**P-103**

Order Plans @ www.LDILine.com

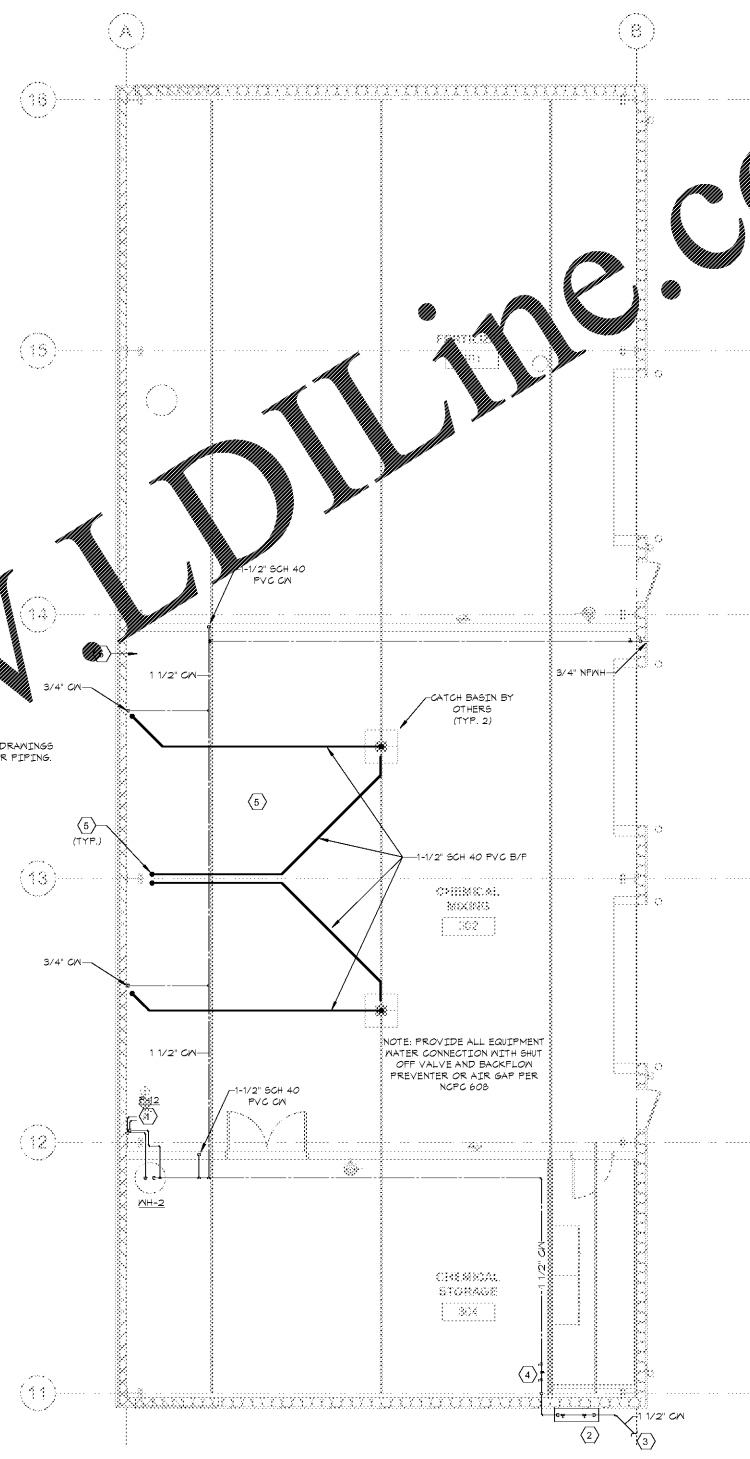

**1 1ST FLOOR - PHASE 3 - PLUMBING**  
P-103 3/16\"/>

- KEY NOTES**  
(APPLY TO THIS SHEET ONLY)
- 1 REFER TO DETAIL 4P-002 FOR INSTALLATION & PIPE SIZES.
  - 2 PROVIDE 1\"/>