


Order Plans @ [www.LDILine.com](http://www.LDILine.com)

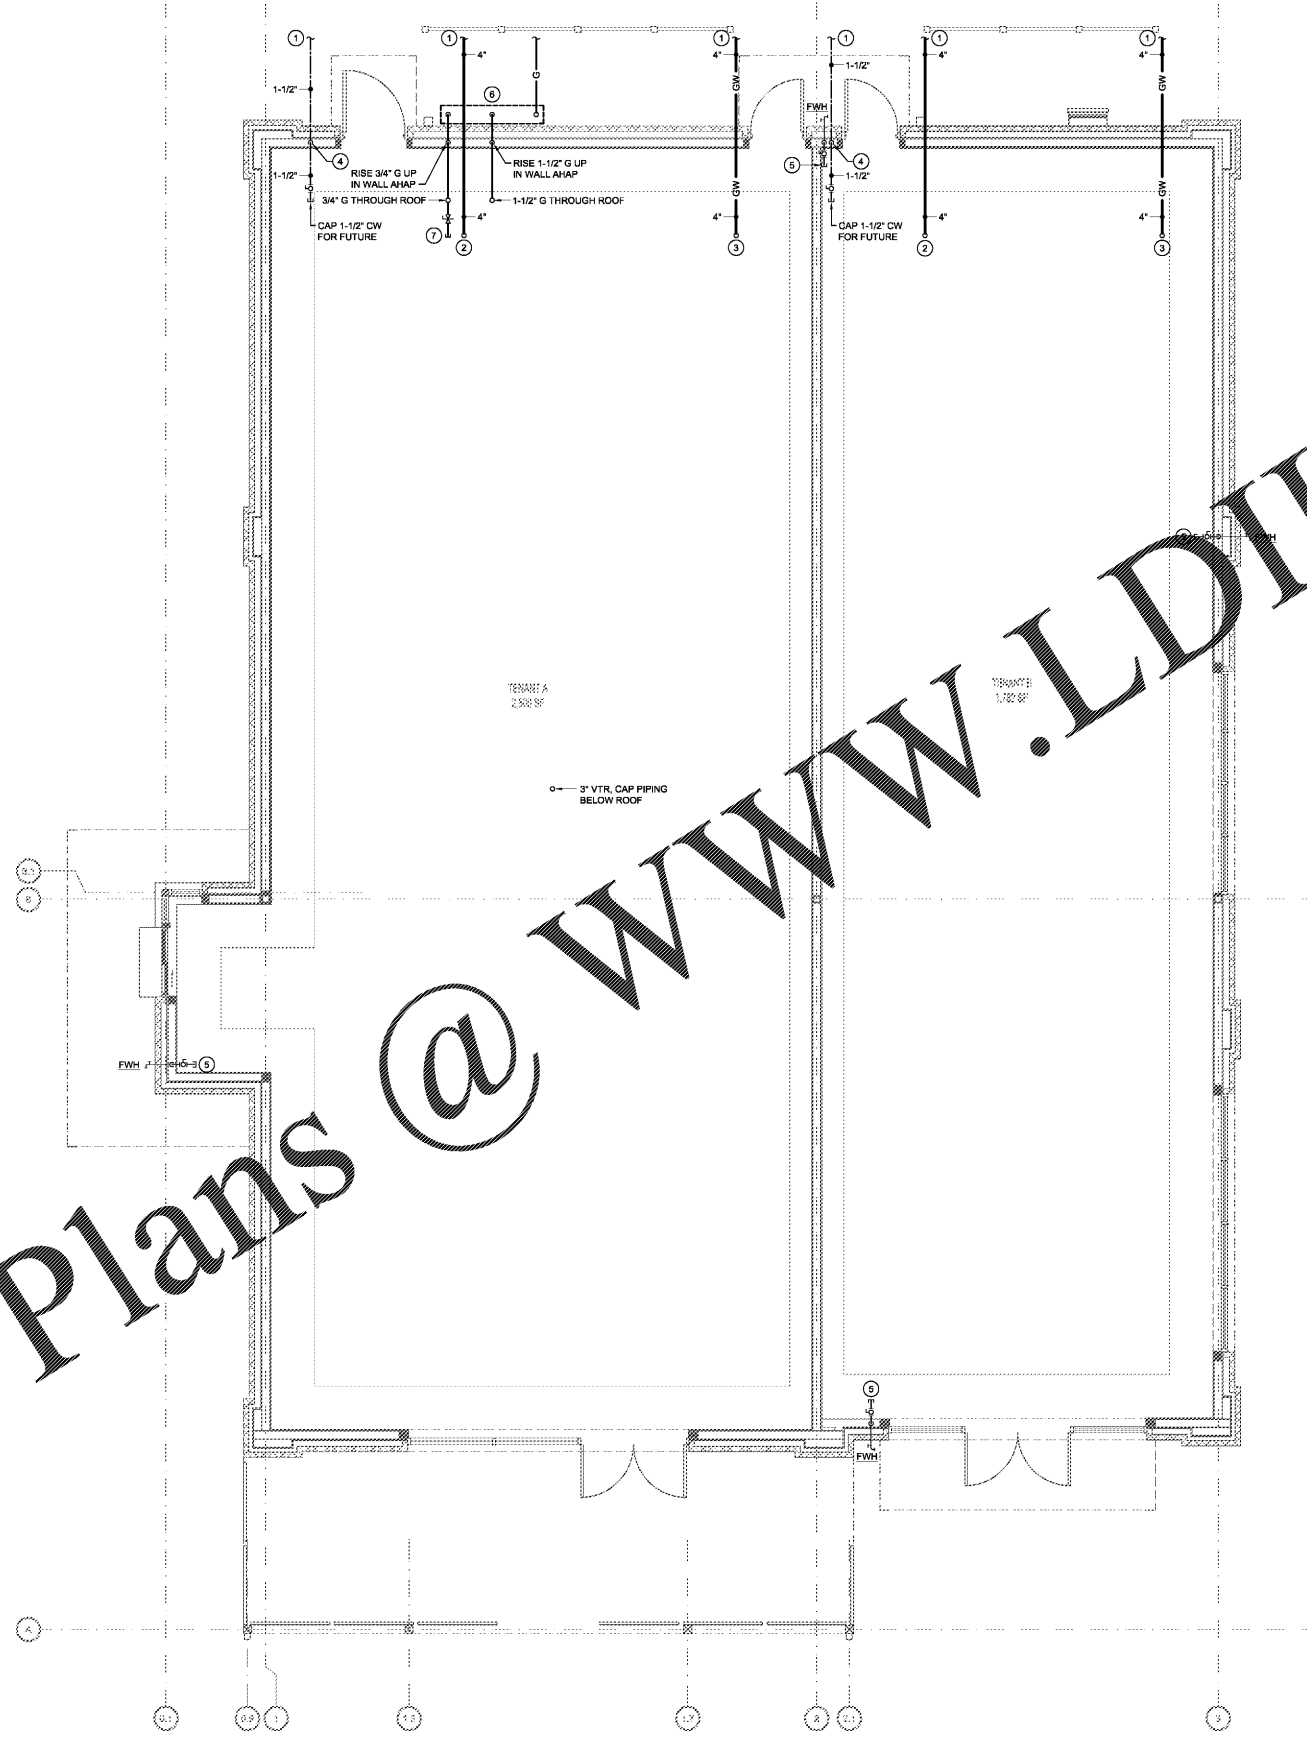



1 PLUMBING FLOOR PLAN  
SCALE: 1/4" = 1'-0"

- KEYED NOTES THIS SHEET**
- REFER TO SITE UTILITY PLAN FOR CONTINUATION OF ALL PIPING ON SITE.
  - 4" SANITARY WASTE PIPING STUBBED OUT MINIMUM 12" ABOVE FINISHED FLOOR WITH CLEANOUT PLUS. MINIMUM INVERT ELEVATION = 36" BELOW FINISHED FLOOR.
  - 4" GREASE WASTE PIPING STUBBED OUT MINIMUM 12" ABOVE FINISHED FLOOR WITH CLEANOUT PLUS. MINIMUM INVERT ELEVATION = 36" BELOW FINISHED FLOOR.
  - 1-1/2" DOMESTIC WATER SERVICE ENTRANCE, RISE UP AS HIGH AS POSSIBLE IN WALL AND PROVIDE BALL VALVE AND CAP FOR FUTURE EXTENSION.
  - RISE UP 1/2" CW IN WALL FROM WALL HYDRANT, PROVIDE BALL VALVE AND CAP 1'-0" BLW ROOF DECK FOR FUTURE EXTENSION.
  - COORDINATE INSTALLATION OF GAS SERVICE AND METER MANIFOLD WITH ELECTRICAL CONTRACTOR. REFER TO NATURAL GAS PIPING SECTION OR GENERAL NOTES ON SHEET P-0 FOR SYSTEM SIZING CRITERIA.
  - VALVE AND CAP 1" GAS FOR FUTURE EXTENSION, TERMINATE 5'-0" ABOVE CEILING.

- GENERAL NOTES THIS SHEET**
- ALL DOMESTIC WATER PIPING AND ALL NATURAL GAS PIPING SHOWN ON THIS SHEET SHALL BE RUN ABOVE CEILINGS IN AREAS WITH CEILINGS AND SHALL BE RUN AS HIGH AS POSSIBLE IN AREAS WITHOUT CEILINGS, UNLESS OTHERWISE NOTED.
  - ALL SANITARY VENT PIPING SHOWN ON THIS SHEET SHALL BE RUN ABOVE CEILINGS IN AREAS WITH CEILINGS AND SHALL BE RUN AS HIGH AS POSSIBLE IN AREAS WITHOUT CEILINGS, UNLESS OTHERWISE NOTED. ALL SANITARY WASTE PIPING SHOWN ON THIS SHEET SHALL BE RUN BELOW FLOORS, UNLESS OTHERWISE NOTED.



**ROBERT JOHNSON**  
architects  
1808 West Morehead St.  
Charlotte, NC 28208  
T 704 / 342.1058  
F 704 / 342.3043

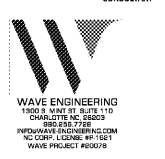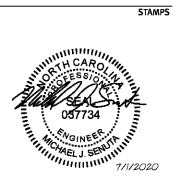

**ALBEMARLE SHOPS**  
CHARLOTTE, NC

PROJECT NUMBER 1913  
ISSUE DATE  
FOR CONSTRUCTION ONLY 07.01.20

**DRAWING DATA**  
DRAWN BY: MIS  
CHECKED BY: BRD/MIS

**SHEET TITLE**  
PLUMBING  
FLOOR PLAN

This drawing is the property of ROBERT JOHNSON ARCHITECTS, INC. and is not to be reproduced or copied in whole or in part. It is only to be used for the project and site specifically identified herein and is not to be used on any other project. It is to be returned upon request.

**SHEET NUMBER**  
P-1.1