




ROBERT JOHNSON
architects
1808 West Morehead St.
Charlotte, NC 28208
T 704 / 342.1058
F 704 / 342.3043

STAMPS



CONSULTANT

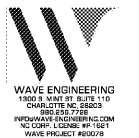

**ALBEMARLE
SHOPS**

CHARLOTTE, NC

PROJECT NUMBER 1913
ISSUE DATE
FOR CONSTRUCTION ONLY 07.01.20


DRAWING DATA
DRAWN BY: MIS
CHECKED BY: BRD/MJS

SHEET TITLE
PLUMBING
ROOF PLAN

This drawing is the property of ROBERT JOHNSON ARCHITECTS, Inc. and is not to be reproduced or copied in whole or in part. It is only to be used for the project and site specifically identified herein and is not to be used on any other project. It is to be returned upon request.

SHEET NUMBER

P-1.2

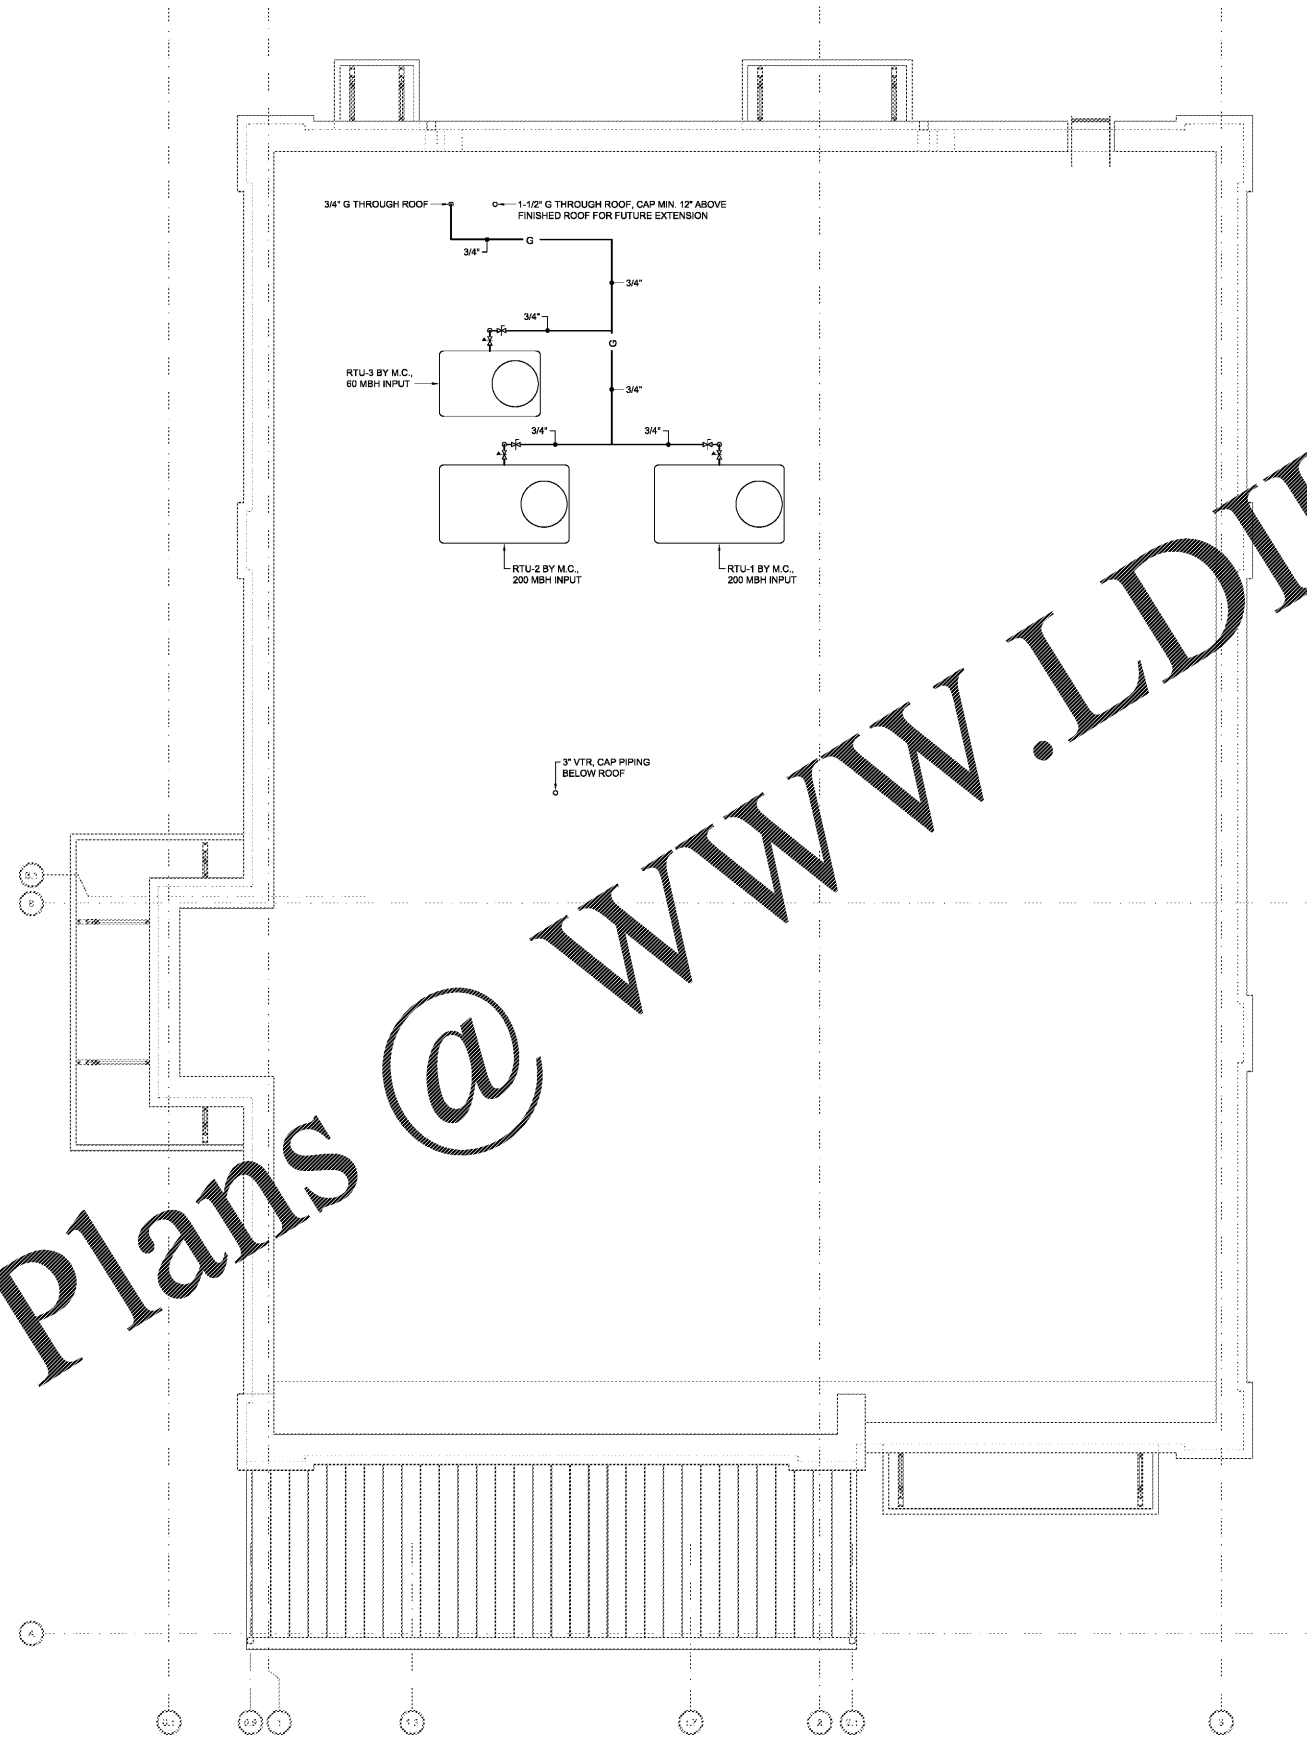

Order Plans @ www.LDILine.com

1 PLUMBING ROOF PLAN
P-1.2 SCALE: 1/4" = 1'-0"

GENERAL NOTES THIS SHEET

- COORDINATE ALL CONNECTION REQUIREMENTS FOR MECHANICAL EQUIPMENT WITH EQUIPMENT SUPPLIER.
- ALL NATURAL GAS PIPING SHOWN ON THIS SHEET SHALL BE RUN ON ROOF, UNLESS OTHERWISE NOTED.